


1 Mezzanine Level 2 +25.00' - Overall Plan

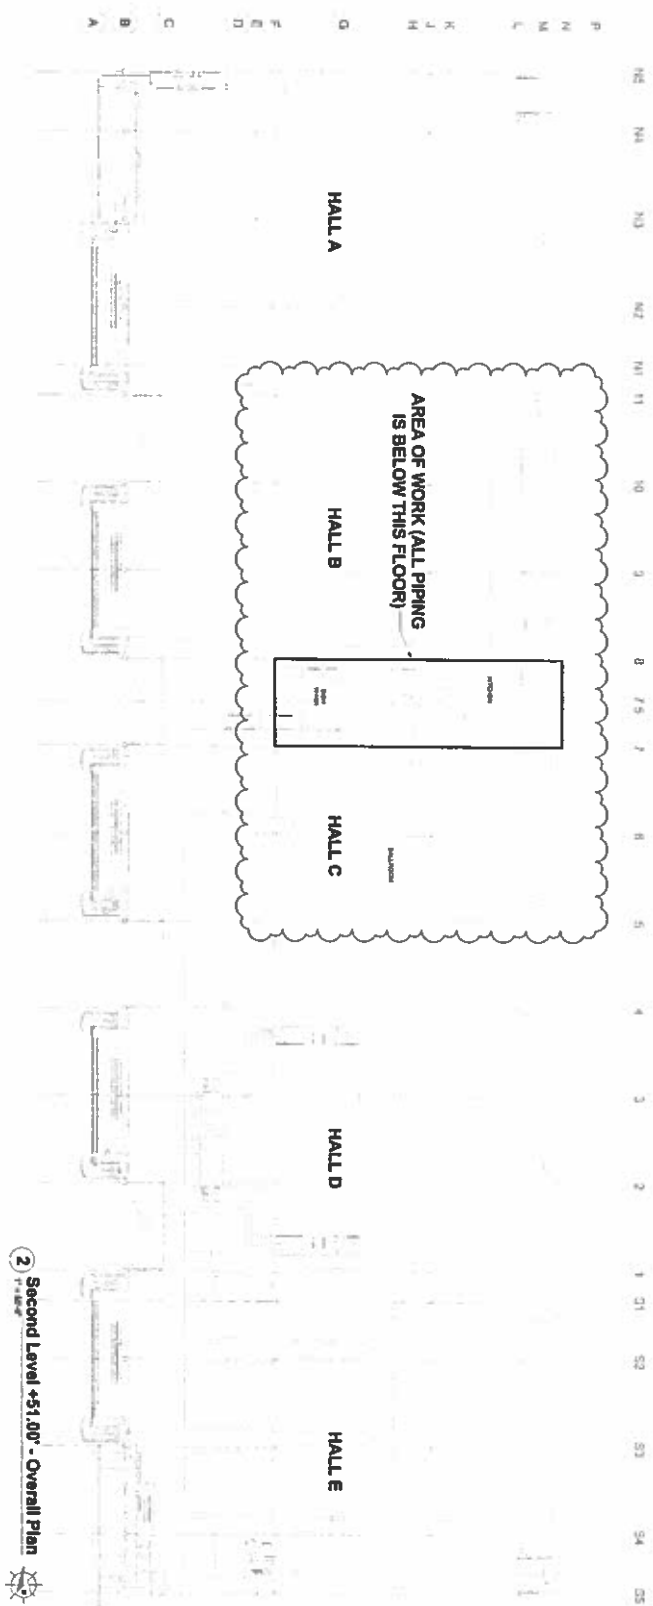

2 Second Level +51.00' - Overall Plan

M100

MEZZANINE LEVEL 2
 OVERALL PLAN

DATE: 07/15/13

PROJECT: GRB KITCHEN PIPE REPLACEMENT

SCALE: AS SHOWN

DESIGNED BY: [Signature]

CHECKED BY: [Signature]

APPROVED BY: [Signature]

KCI

CONSTRUCTION MANAGEMENT

1302919 0 14.00 P&I

DATE: 07/15/13

PROJECT: GRB KITCHEN PIPE REPLACEMENT

SCALE: AS SHOWN

DESIGNED BY: [Signature]

CHECKED BY: [Signature]

APPROVED BY: [Signature]

GRB Kitchen Pipe Replacement

City of Houston & Houston Fire Corp

1001 Avenida de las Americas, Houston TX 77056

NO.	REVISION	DATE





8



9



10

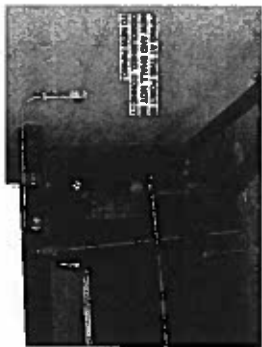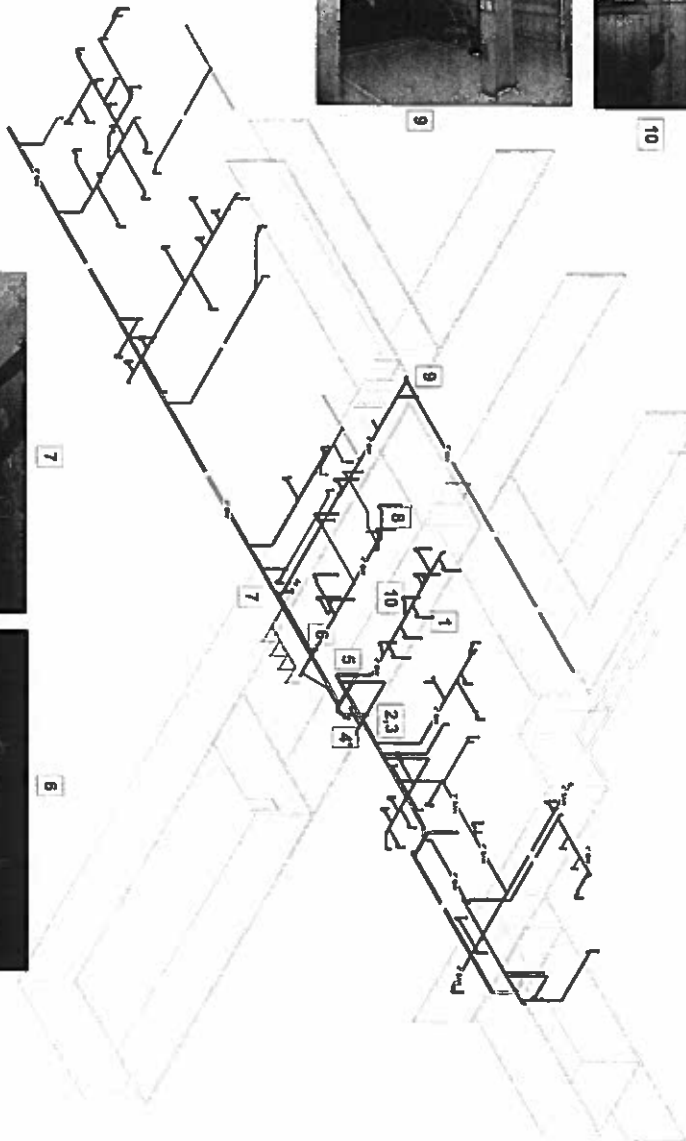

7




6



1



2

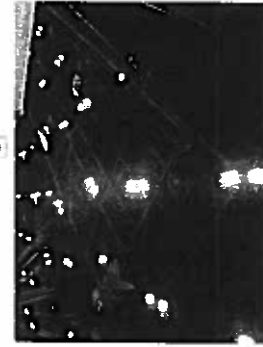

3



5



4

SHEET HAS BEEN ADDED


1 PIPING SCHEMATIC

PROJECT NO.	719223
DATE	1/25/2015
DRAWN BY	[Signature]
CHECKED BY	[Signature]
SCALE	AS SHOWN
TITLE	GRB Kitchen Pipe Replacement
DATE	1/25/2015
BY	[Signature]
CHECKED	[Signature]
DATE	1/25/2015
PROJECT NO.	719223
DATE	1/25/2015
DRAWN BY	[Signature]
CHECKED BY	[Signature]
SCALE	AS SHOWN
TITLE	GRB Kitchen Pipe Replacement
DATE	1/25/2015
BY	[Signature]
CHECKED	[Signature]
DATE	1/25/2015

KCI TECHNOLOGIES
 ENGINEER
 PLUMBER
 DESIGNER
 CONSTRUCTION MONITOR
 200 W. 14th St. Suite 100
 Houston, TX 77002
 P.O. Box 10000
 Houston, TX 77241
 Tel: 713.261.1000
 Fax: 713.261.1001
 www.kci-tech.com

GRB Kitchen Pipe Replacement
 City of Houston & Houston First Care
 1601 Avenida de las Americas, Houston TX 77016

REVISION NO.	DESCRIPTION	DATE

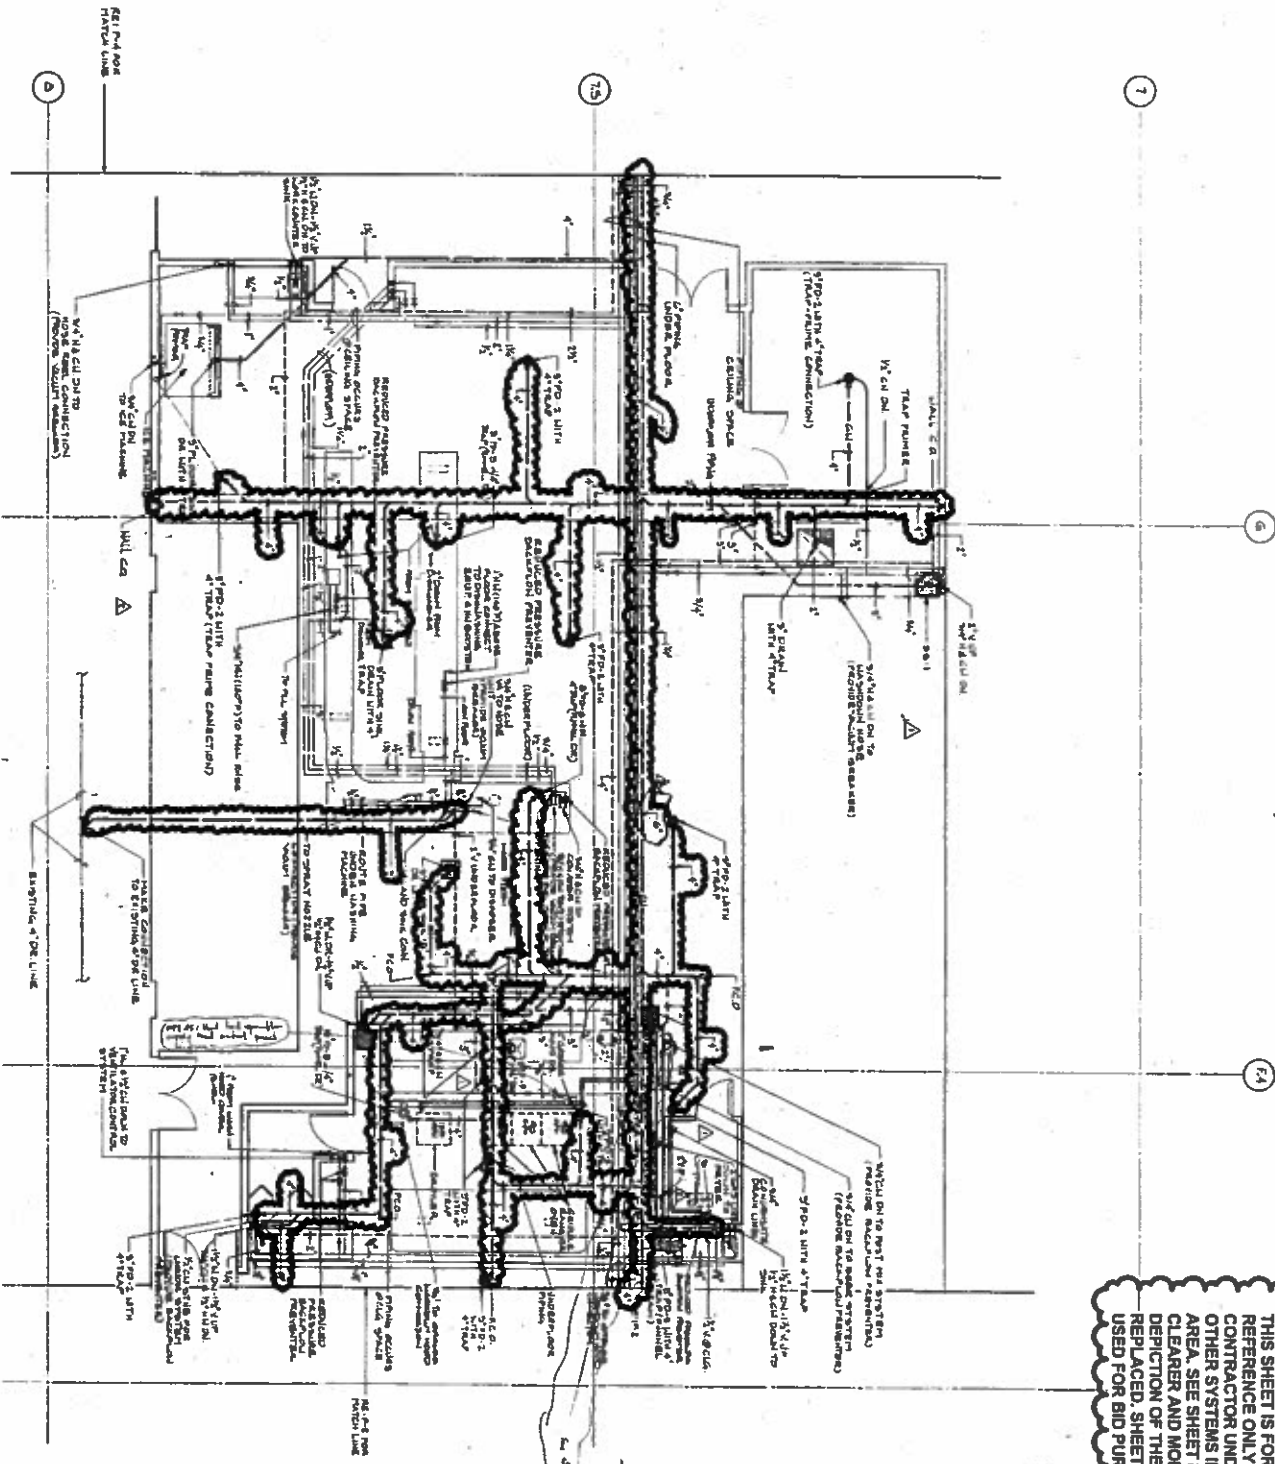

HEAVY CLOUDS
 INDICATE PIPE TO BE REPLACED.
 THIS SHEET IS FOR GENERAL
 REFERENCE ONLY AND TO HELP
 CONTRACTOR UNDERSTAND
 OTHER SYSTEMS IN THE PROJECT
 AREA. SEE SHEET M200 FOR A
 CLEARER AND MORE ACCURATE
 DEPICTION OF THE PIPES TO BE
 REPLACED. SHEET M200 IS TO BE
 USED FOR BID PURPOSES.

1 KITCHEN PLUMBING PLAN - AREA A


M103.BA

DATE: 10/26/23
 DRAWN BY: [Signature]
 CHECKED BY: [Signature]
 PROJECT: GRB Kitchen Pipe Replacement

KCI
 CONSULTING ENGINEERS
 11111 RICHMOND AVE., SUITE 100
 HOUSTON, TEXAS 77036
 PHONE: 281.416.1111
 WWW.KCI-ENGINEERS.COM

GRB Kitchen Pipe Replacement
 City of Houston & Houston Fire Dept.
 5001 Avenida de los Americas, Houston TX 77056

NO.	REVISION	DATE

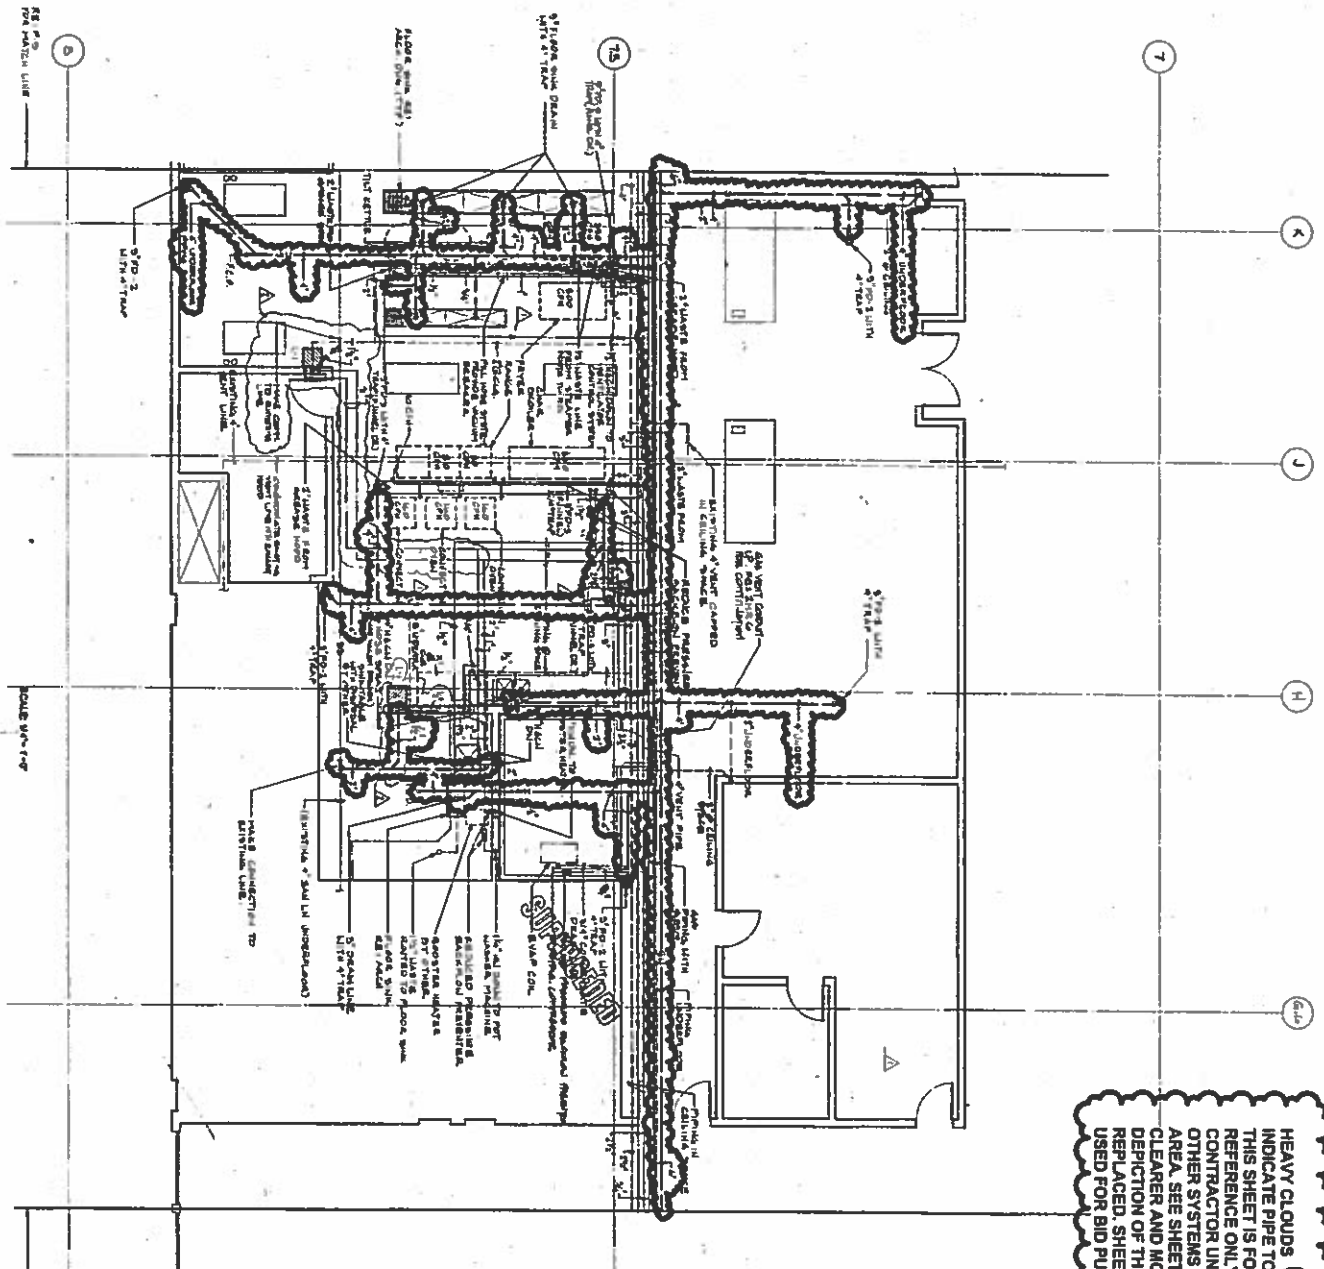

HEAVY CLOUDS
 INDICATE PIPE TO BE REPLACED.
 THIS SHEET IS FOR GENERAL
 REFERENCE ONLY AND TO HELP
 CONTRACTOR UNDERSTAND
 OTHER SYSTEMS IN THE PROJECT
 AREA. SEE SHEET M200 FOR A
 CLEARER AND MORE ACCURATE
 DEPICTION OF THE PIPES TO BE
 REPLACED. SHEET M200 IS TO BE
 USED FOR BID PURPOSES.


1 KITCHEN PLUMBING PLAN - AREA B

PROJECT NO. 140221
 SHEET NO. M103.08B
 DATE 1/22/09
 DRAWN BY [Signature]
 CHECKED BY [Signature]
 APPROVED BY [Signature]

KCI
 TECHNOLOGIES
 2800 WEST 13TH STREET
 SUITE 100
 FORT WORTH, TX 76102
 TEL: 817-332-4400
 FAX: 817-332-4401
 Texas Registered Professional Engineer # 26971

GRB Kitchen Pipe Replacement
 City of Houston & Houston Fire Dept.
 1001 Avenida de las Americas, Houston TX 77058

M103.08B

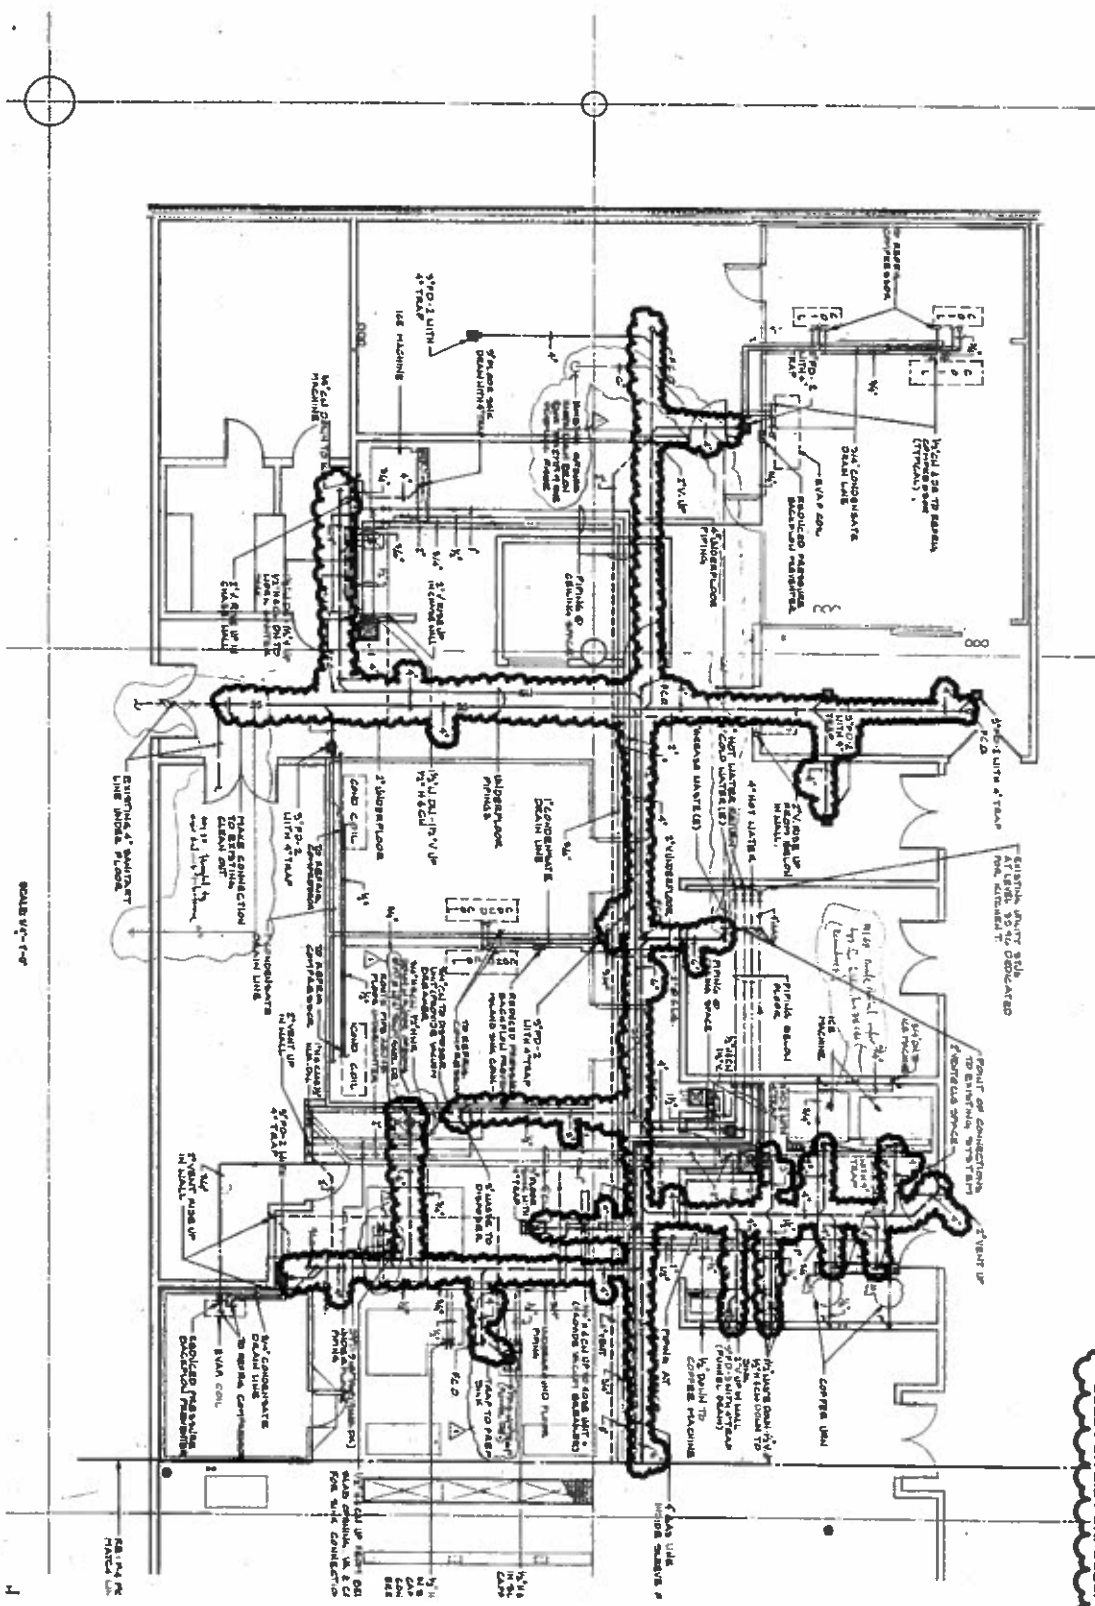

SCALE: 1/4" = 1'-0"

1 KITCHEN PLUMBING PLAN - AREA C

HEAVY CLOUDS INDICATE PIPE TO BE REPLACED. THIS SHEET IS FOR GENERAL CONTRACTOR UNDERSTAND OTHER SYSTEMS IN THE PROJECT AREA. SEE SHEET M200 FOR A CLEARER AND MORE ACCURATE DEPICTION OF THE PIPES TO BE REPLACED. SHEET M200 IS TO BE USED FOR BID PURPOSES.

M103.6C

KITCHEN PLUMBING PLAN - AREA C

DATE: 10/28/09

PROJECT: GRB KITCHEN PIPE REPLACEMENT

SCALE: 1/4" = 1'-0"

KCI

CONSTRUCTION CONSULTANTS, INC.

1100 WEST 19TH STREET, SUITE 100
 FORT WORTH, TEXAS 76102
 PHONE: 817.339.4400
 FAX: 817.339.4401
 WWW.KCI-CO.COM

GRB Kitchen Pipe Replacement

City of Houston & Houston Fire Corp

5001 Avenida de las Americas, Houston TX 77056

NO.	REVISION	DATE