

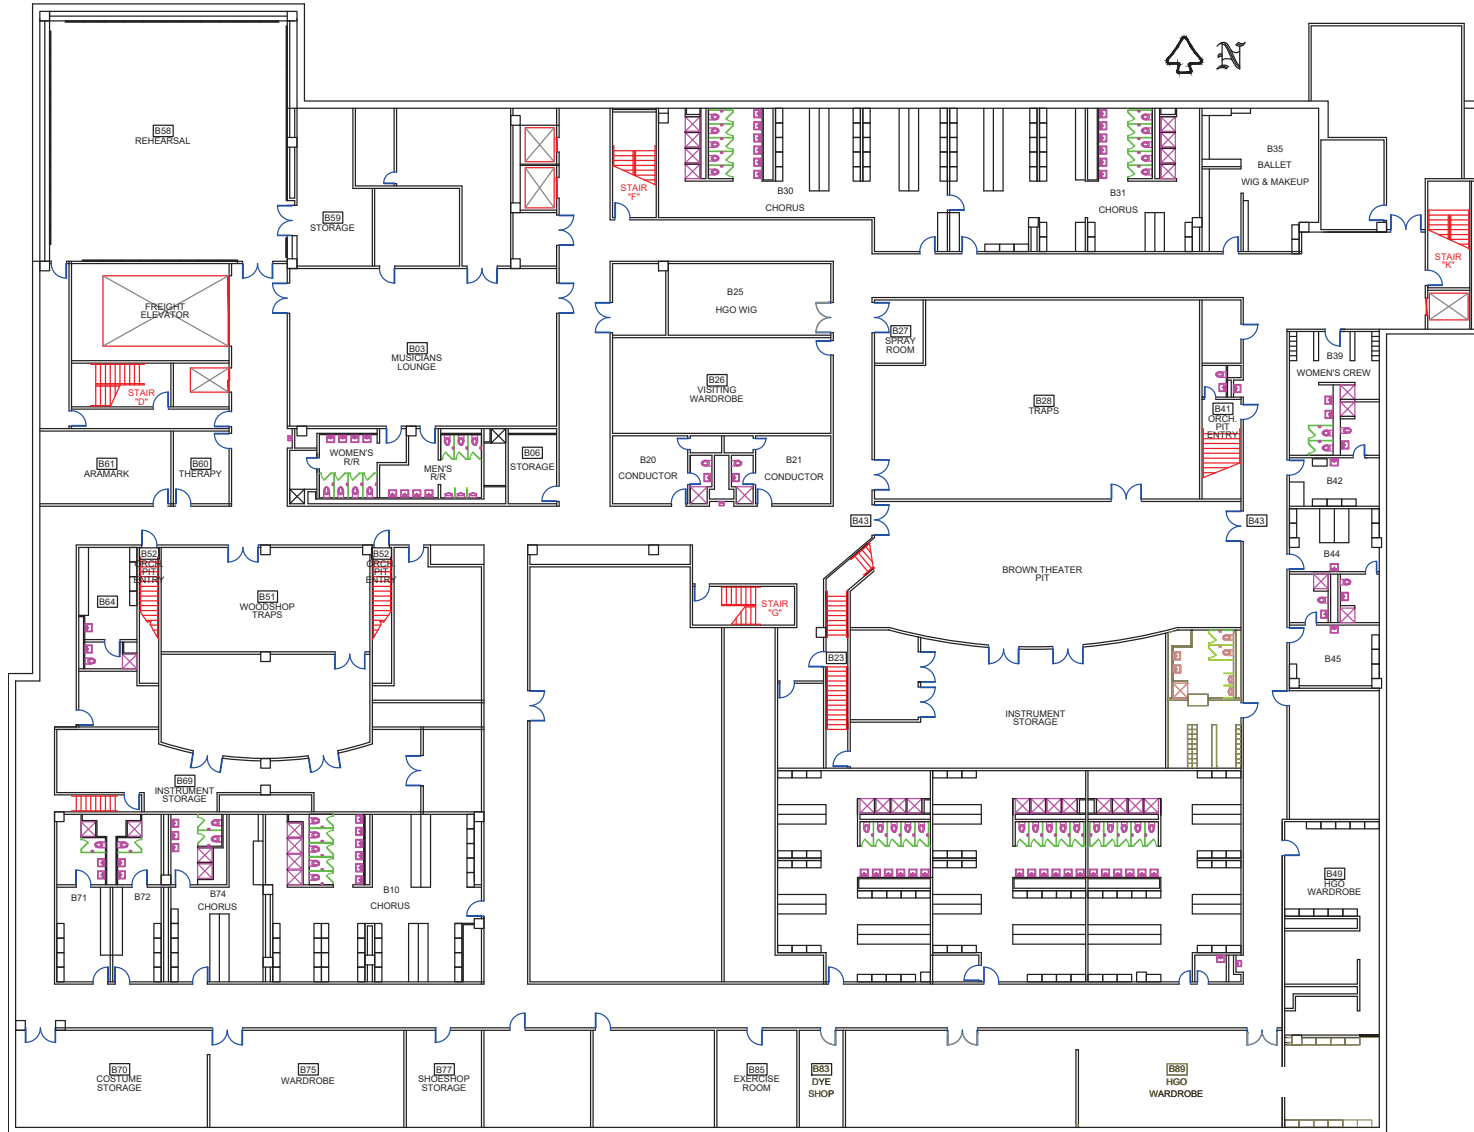


**BASEMENT LEVEL**

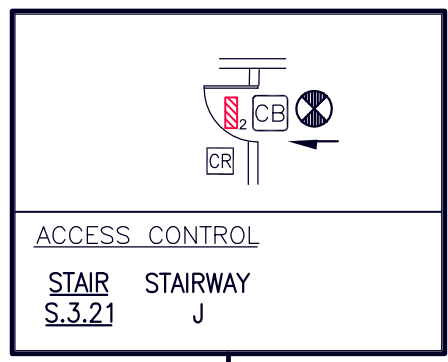

# Wortham THEATER CENTER

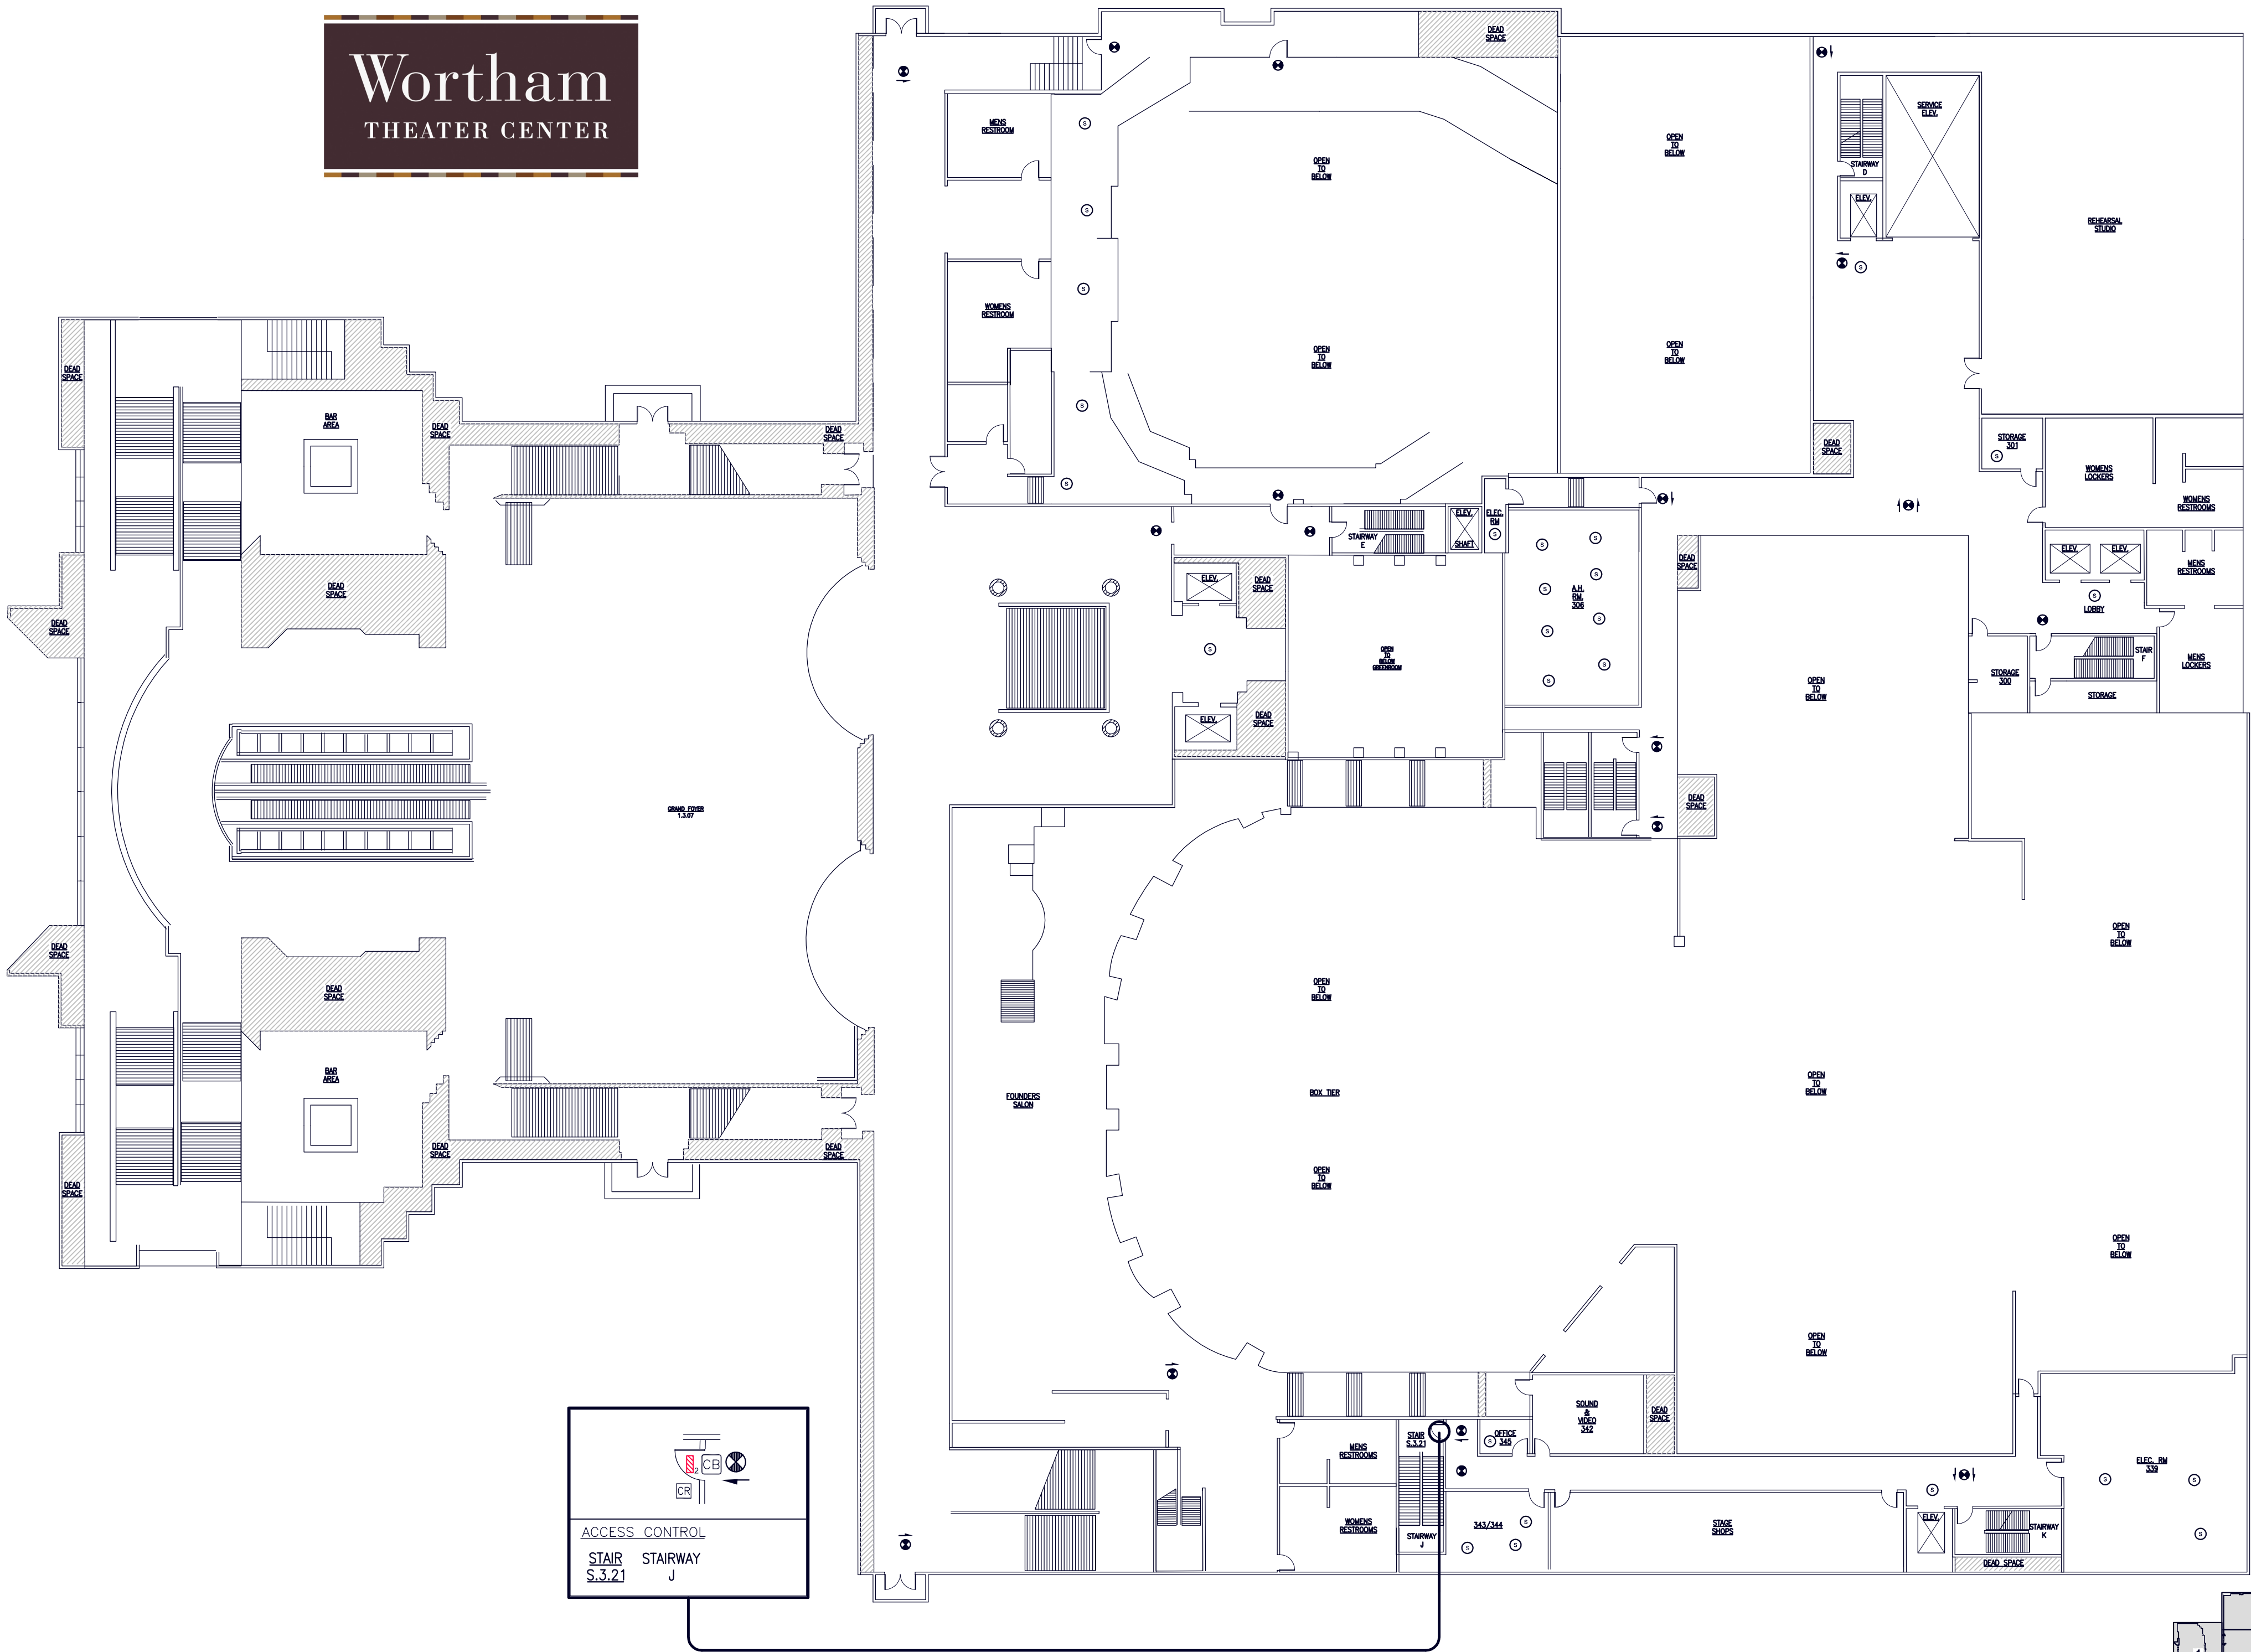


	Magnetic Lock
	Elect. STRIKE
	Exit Sign
	Card Reader
	Fire Pull
	Exit Button
	Motion Detector
	Door Contact

General Notes  
SYMBOL LEGEND


**AVG**  
Systems, Inc.  
Created by Neevia docuPrinter LT trial version <http://www.neevia.com>

Project Name and Address  
**WORTHAM CENTER**  
510 PRESTON  
HOUSTON, TEXAS 77002

Drawing Title	FLOOR 3
FLOOR PLANS (ACCESS CONTROL)	
Date	AUG 6, 2004
Scale	1/8" = 1'
Engineered By	PC
Approved By	PC

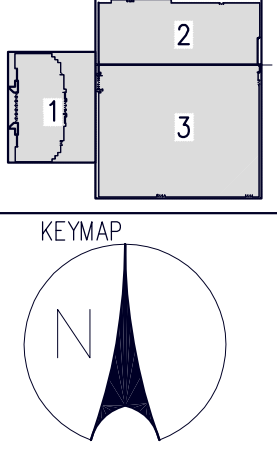

## WORTHAM THEATER CENTER (FLOOR 3)

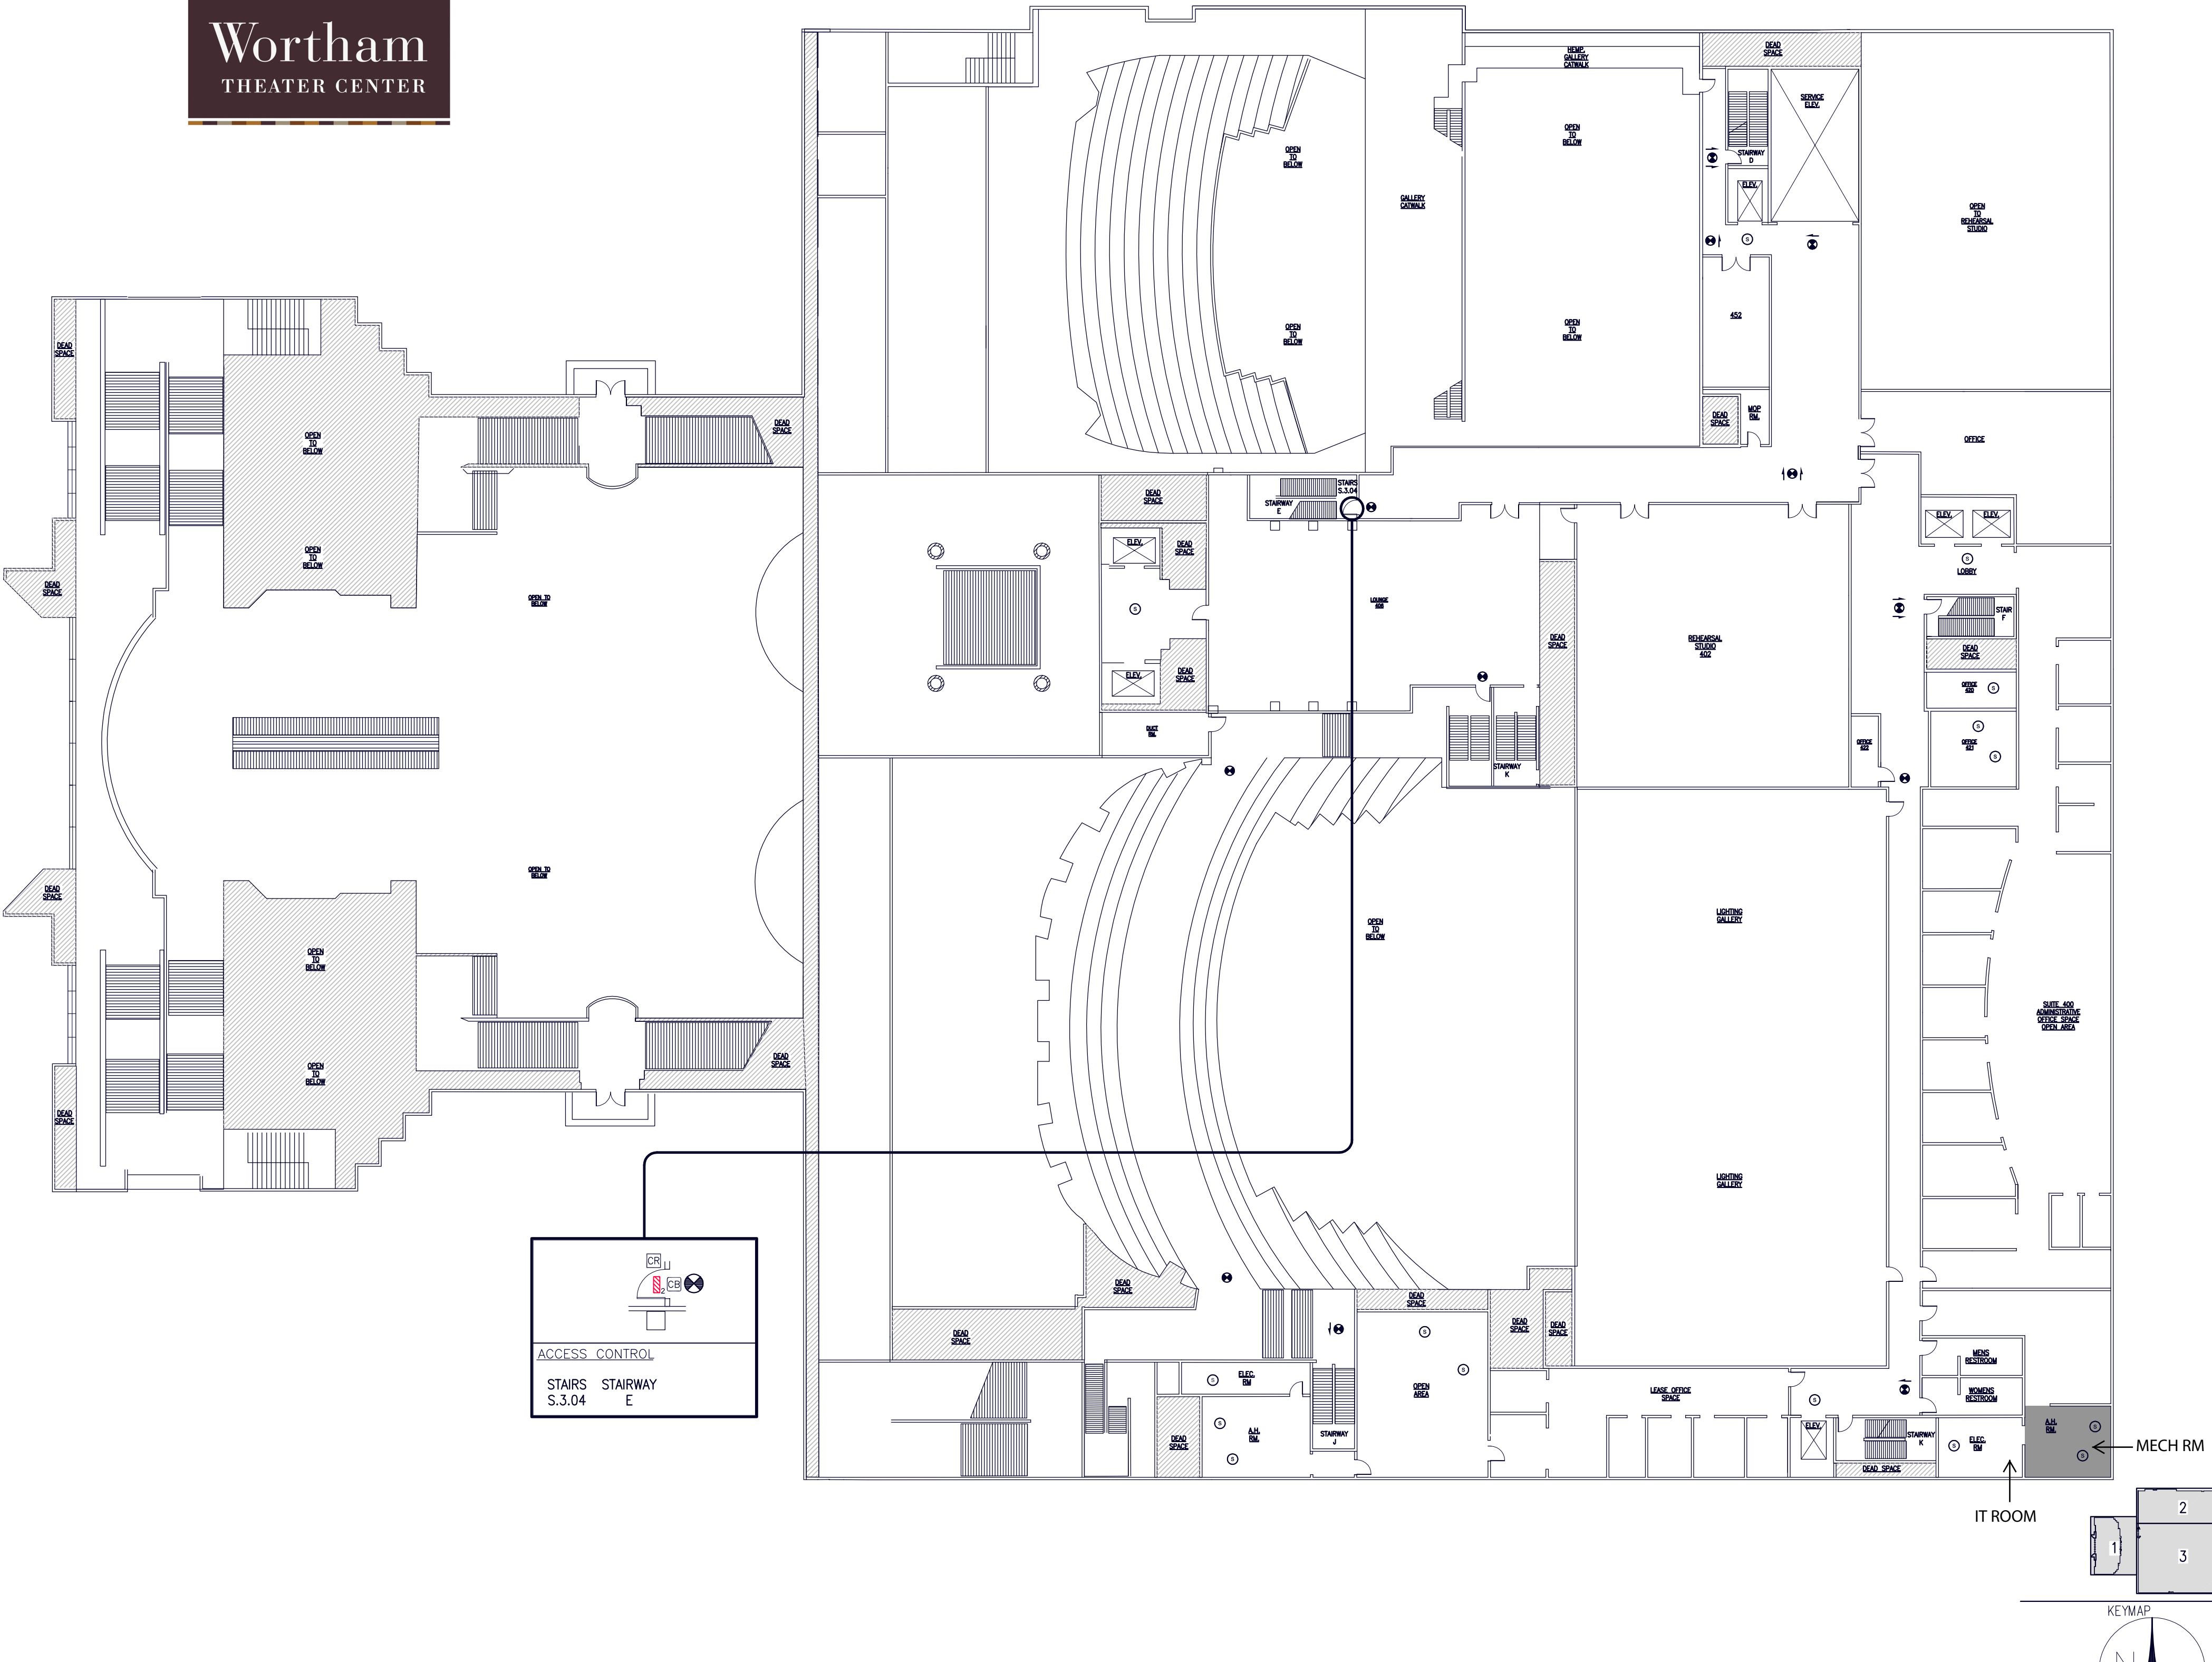


General Notes

SYMBOL LEGEND

	Magnetic Lock
	Elect. STRIKE
	Exit Sign
	Card Reader
	Fire Pull
	Exit Button
	Motion Detector
	Door Contact

General Notes

SYMBOL LEGEND

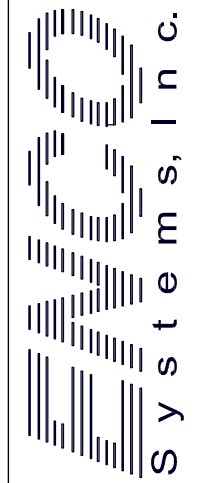

Created by Neevia docuPrinter LT trial version <http://www.neevia.com>

Project Name and Address

**WORTHAM CENTER**  
510 PRESTON  
HOUSTON, TEXAS 77002

Drawing Title  
**FLOOR 4**

**FLOOR PLAN (ACCESS CONTROL)**

Date  
AUG 9, 2004


Scale  
1/8" = 1'

Prepared By  
PC


Approved By  
PC

70745-FL4.

**WORTHAM THEATER CENTER (FLOOR 4)**


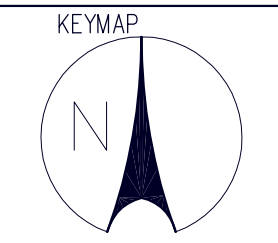


# Wortham THEATER CENTER

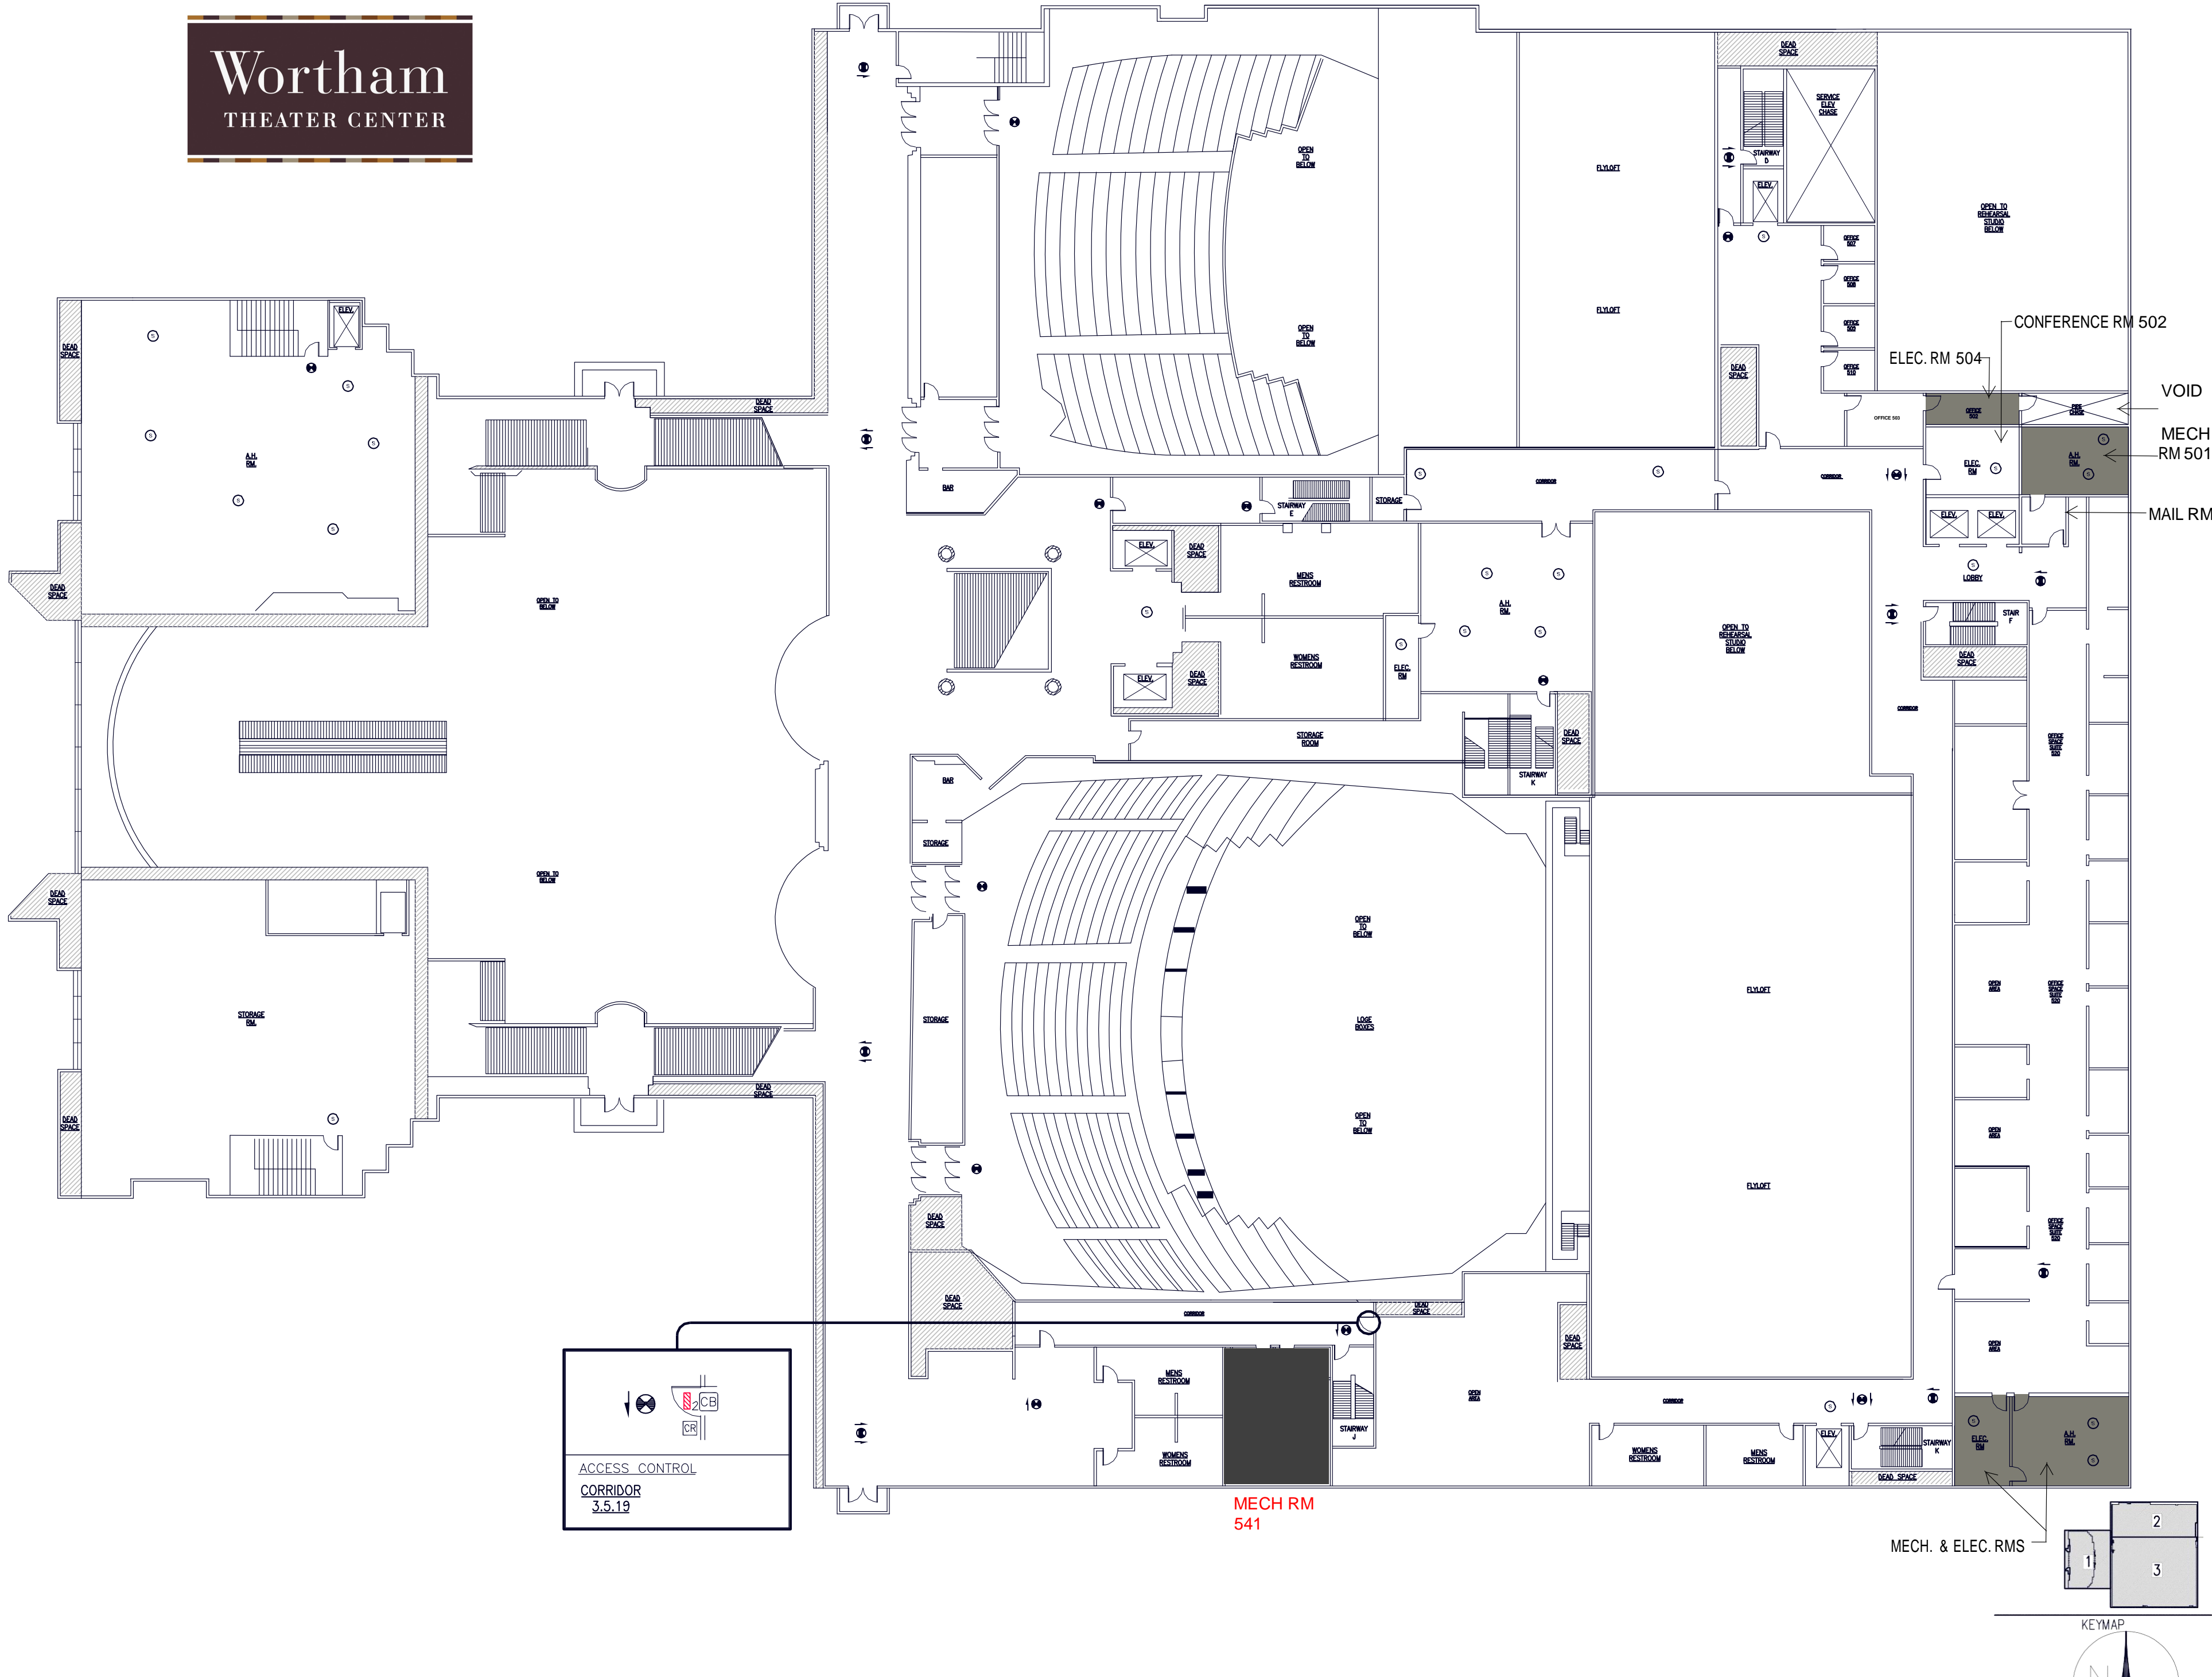


General Notes  
SYMBOL LEGEND

	Magnetic Lock
	Elect. STRIKE
	Exit Sign
	Card Reader
	Fire Pull
	Exit Button
	Motion Detector
	Door Contact

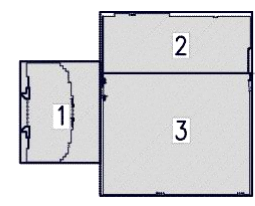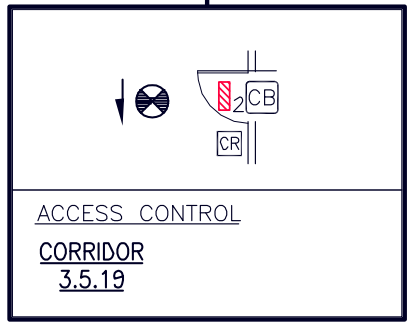

## WORTHAM THEATER CENTER (FLOOR 5)

General Notes  
SYMBOL LEGEND

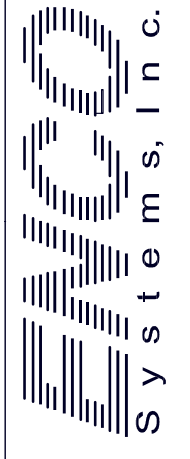

Created by Neevia docuPrinter LT trial version <http://www.neevia.com>

Project Name and Address  
WORTHAM CENTER  
510 PRESTON  
HOUSTON, TEXAS 77002

Drawn by The  
FLOOR 5  
FLOOR PLAN (ACCESS CONTROL)  
Date  
AUG 11, 2004  
Scale  
1/8" = 1'  
Prepared by  
PC  
Reviewed by  
PC

70745-FL5.  
Created by Neevia docuPrinter LT trial version



